

3/21/2022



# First Presbyterian Church Proposal

*'natura practicus'*

IDES 115

Immersive Learning Project

# FIRST PRESBYTERIAN CHURCH

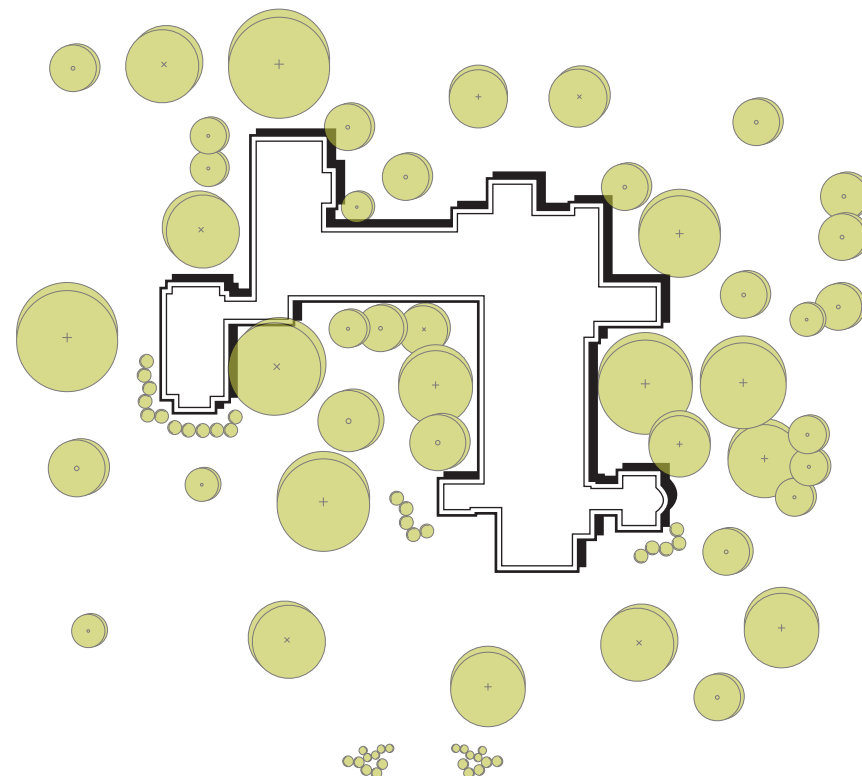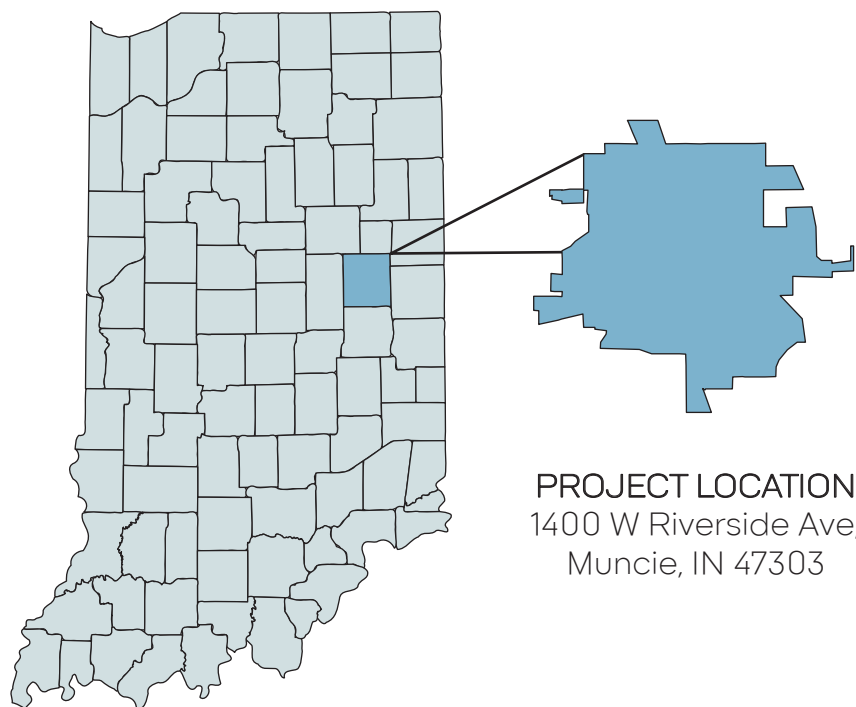


SYMBOL	SYMBOL NAME
	Finish Type
	Wall Type
	Furniture Type
	Door Type
	Room Tag
	Elevation Mark
	Section
	Interior Elevation Head
	Wall Outlet
	Double Switch


SHEET LIST	
Sheet Number	Sheet Name
00	Cover Sheet
A1	Partition Floor Plan
A2	Finish Floor Plan
A3	Finish Schedule + Specs
A4	Keyed Furniture Plan
A5	Reflected Ceiling Plan
A6.1	Interior Elevations - East Room
A6.2	Interior Elevations - West Room
A7	Architectural Details - Carpet + Wall
A8	Electric, Power, + Data
D1	Demo Plan

**PROJECT DESCRIPTION**

Positioned on the eastern edge of Ball State's Campus, First Presbyterian Church is located at 1400 W. Riverside Ave. on the corner of Riverside and New York Avenues. As this projects aims to renovate a study room and storage space, a natural color scheme was used to invite students into a calm and neutral environment; meanwhile the storage space is clean + practical for school purposes. 'Natura Practicus' explores the idea of providing practical services in a simplistic + tastefully minimalist aesthetic, so as to compliment the architectural style of the building.

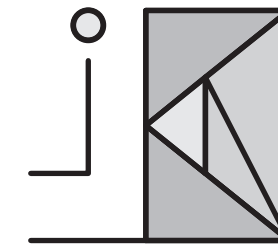

21 MARCH 2022

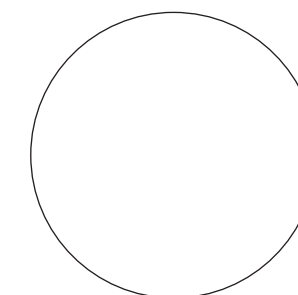


INTERIOR MATERIALS  
+ APPLICATIONS

**IDES 115**

COVER  
SHEET


DRAWN BY:  
Blankenberger | Bulmahn  
Johnson | Laird | Turner  
CHECKED BY:

SHEET  
**00**

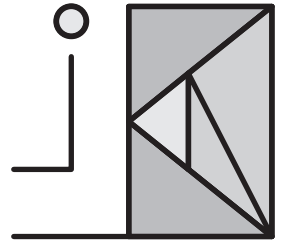

21 MARCH 2022

**\*Existing Ceiling Fixtures**  
(lights + fans) are to be replaced with new

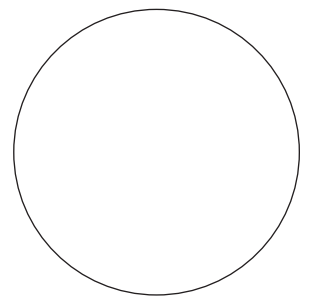

INTERIOR MATERIALS  
+ APPLICATIONS


**IDES 115**

DEMO  
PLAN


DRAWN BY:  
Blankenberger | Bulmahn  
Johnson | Laird | Turner  
CHECKED BY:

SCALE: 1/4" = 1'-0"


SHEET  
**D1**

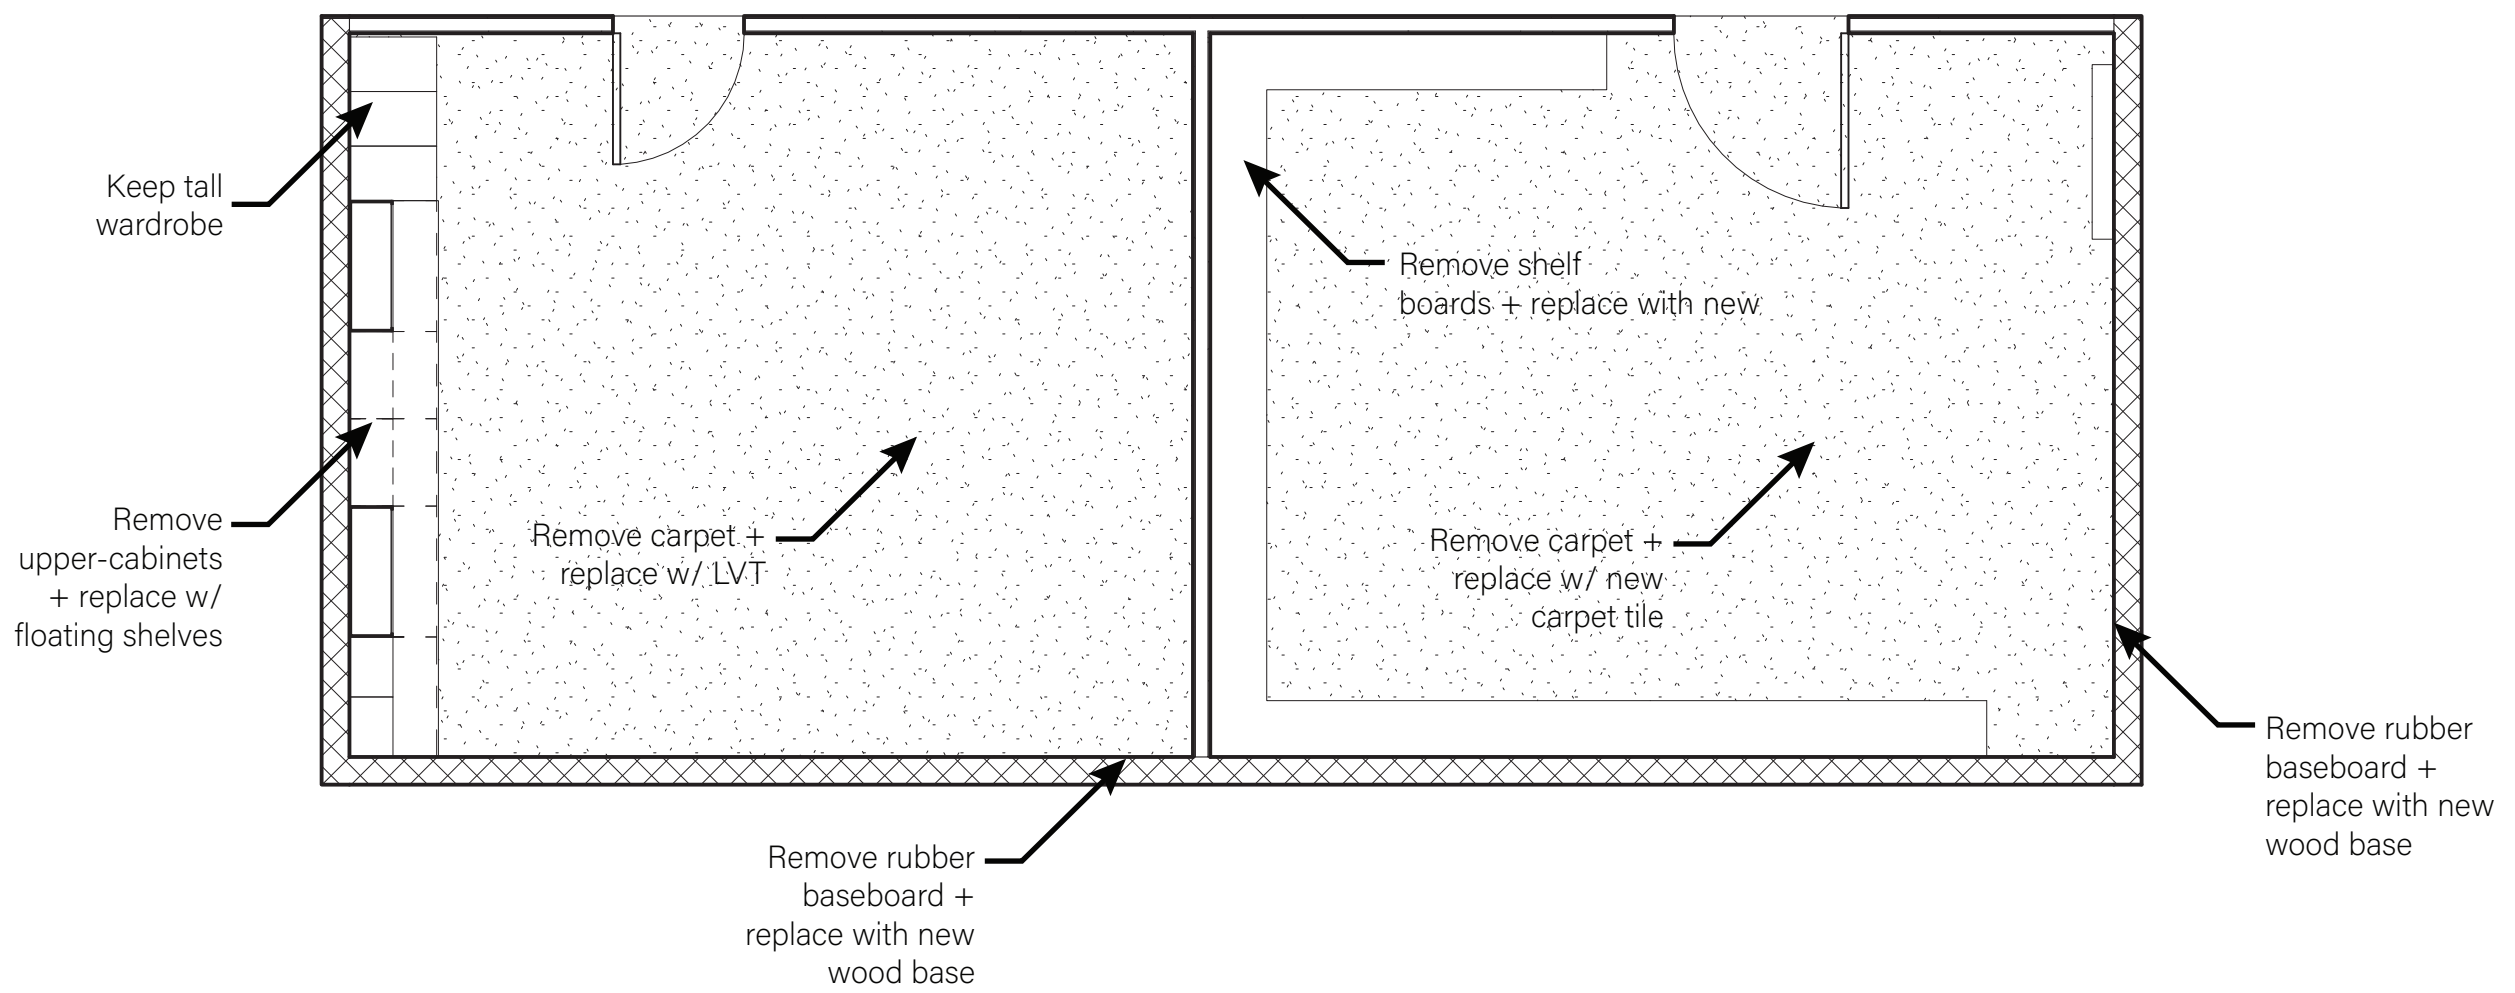

① Level 1 Demo Plan  
1/4" = 1'-0"

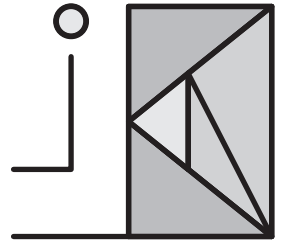

21 MARCH 2022

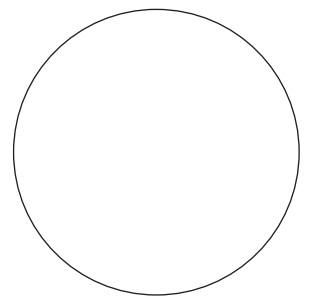

INTERIOR MATERIALS  
+ APPLICATIONS


# IDES 115

PARTITION  
FLOOR  
PLAN

DRAWN BY:  
Blankenberger | Bulmahn  
Johnson | Laird | Turner  
CHECKED BY:


SCALE: 1/4" = 1'-0"

SHEET  
**A1**

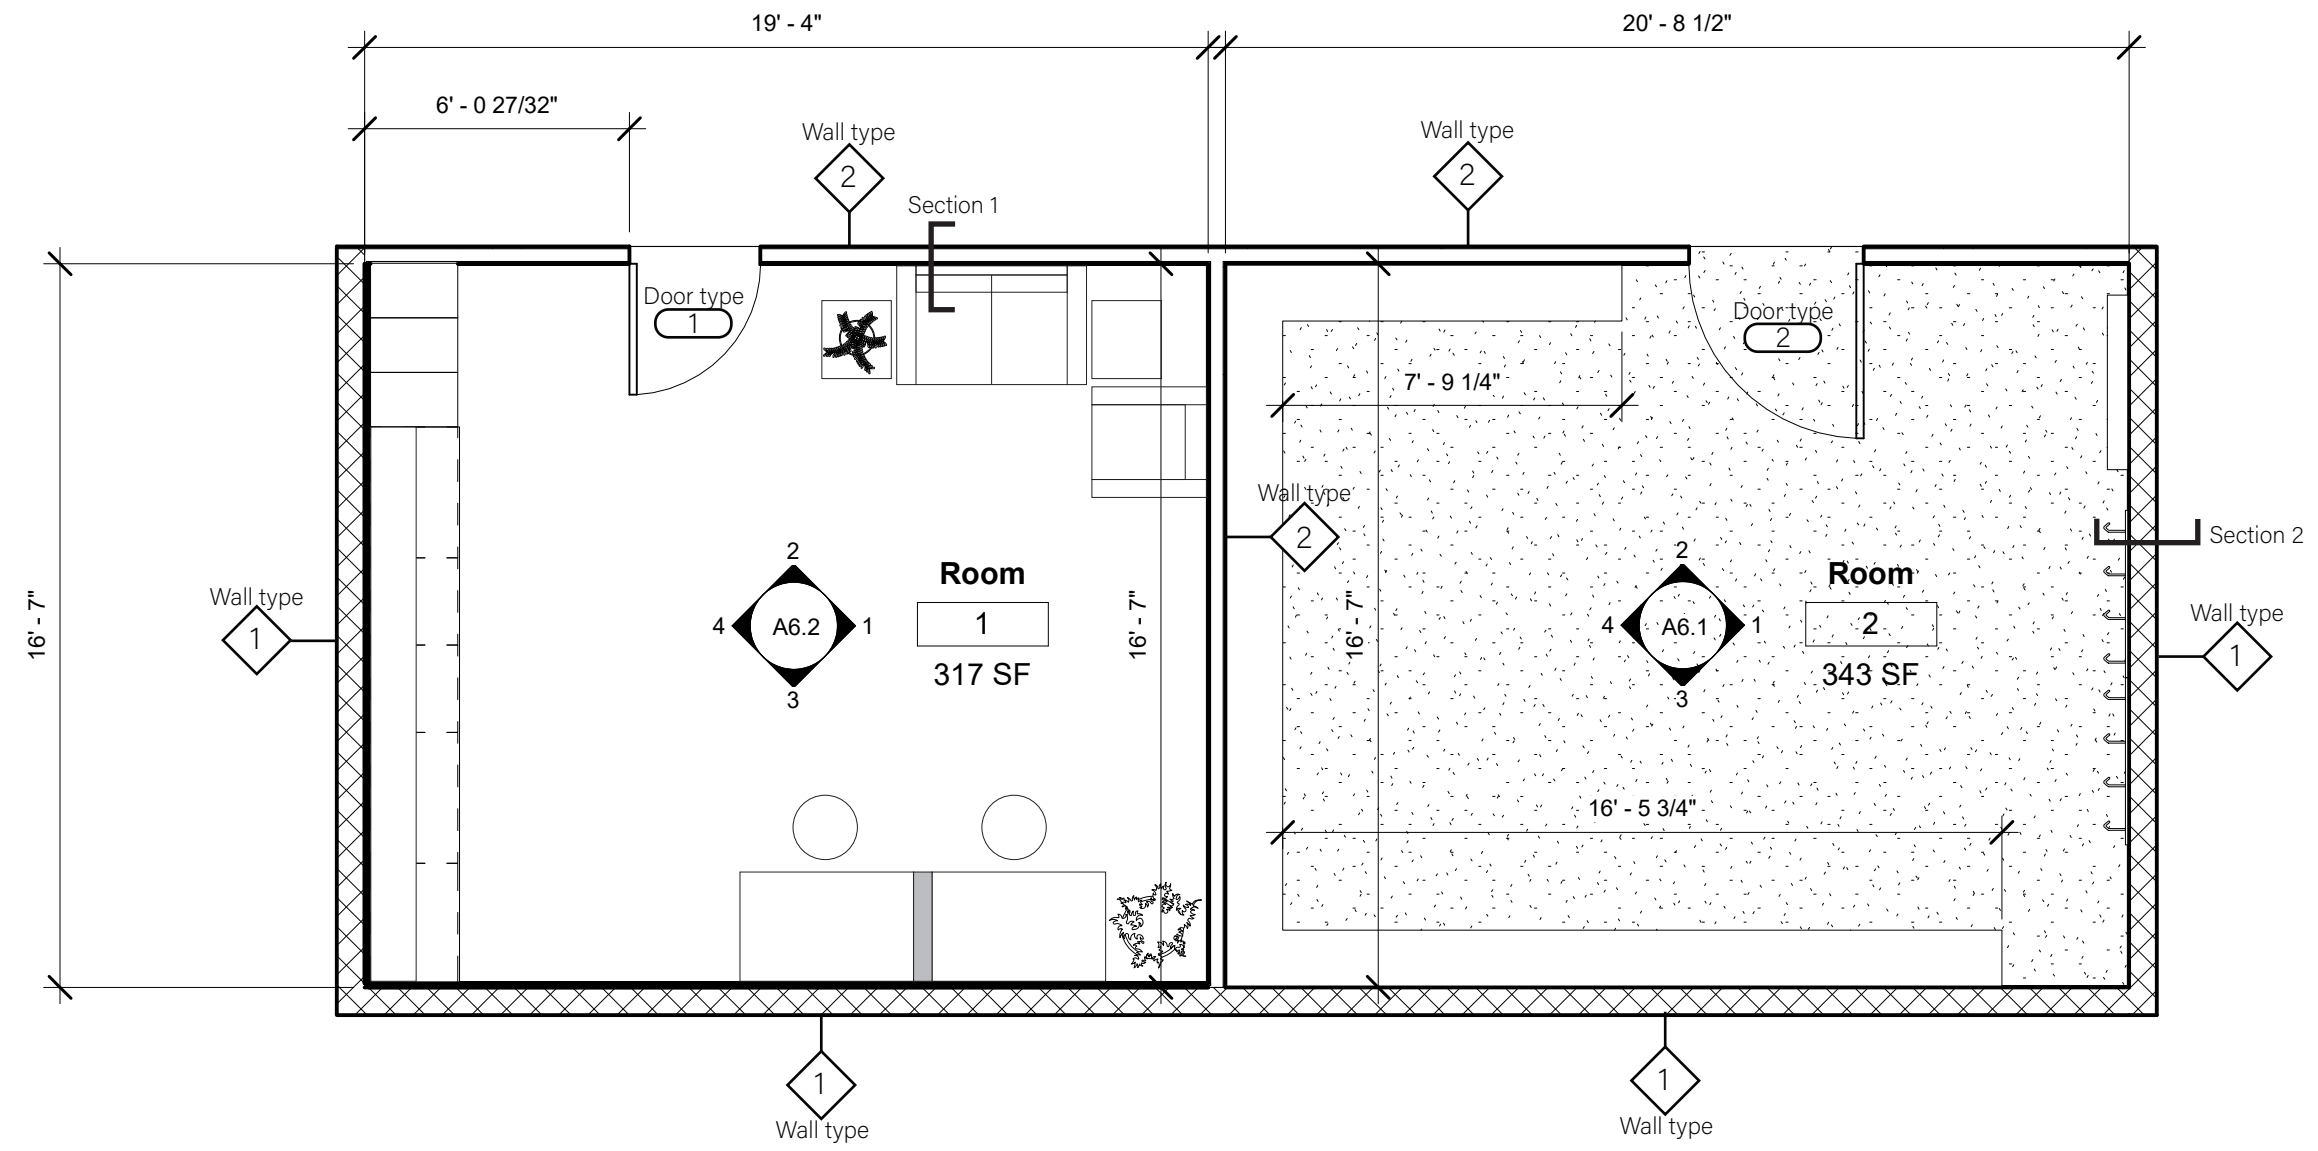


① Level 1  
1/4" = 1'-0"



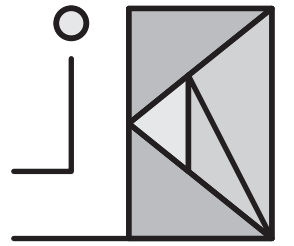

21 MARCH 2022

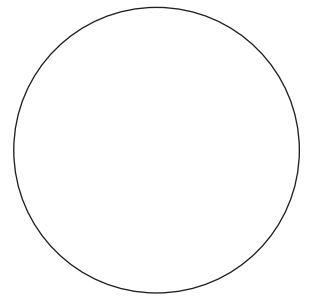

INTERIOR MATERIALS  
+ APPLICATIONS


IDES 115

FINISH  
FLOOR  
PLAN


DRAWN BY:  
Blankenberger | Bulmahn  
Johnson | Laird | Turner  
CHECKED BY:

SCALE: 1/4" = 1'-0"


SHEET  
A2

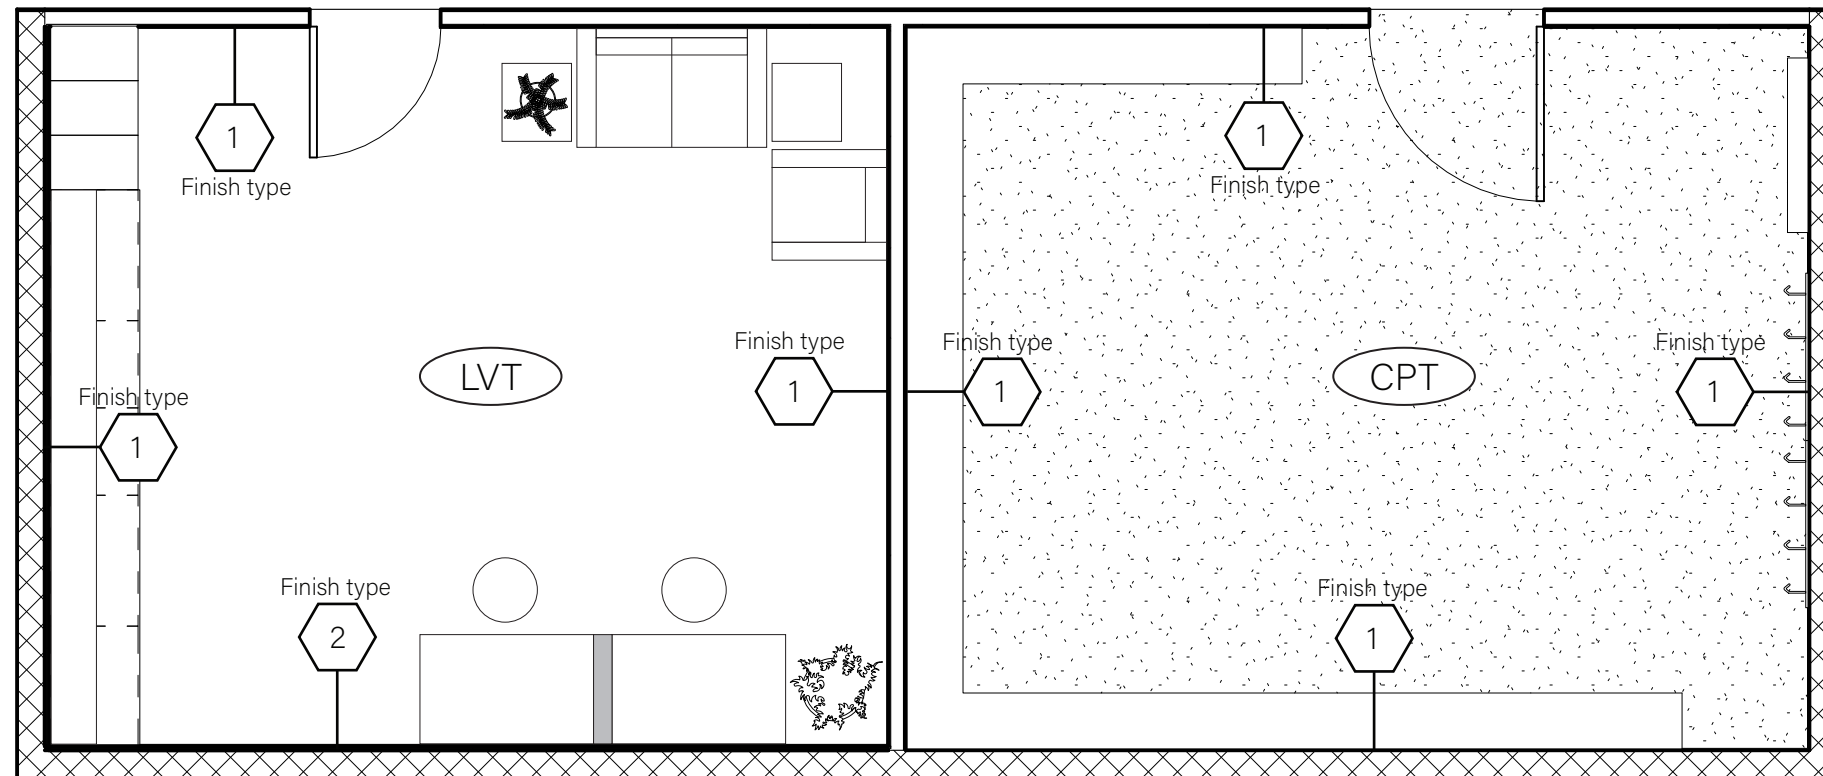

① Finish Schedule  
1/4" = 1'-0"

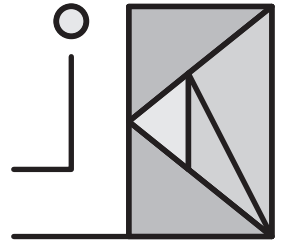

21 MARCH 2022

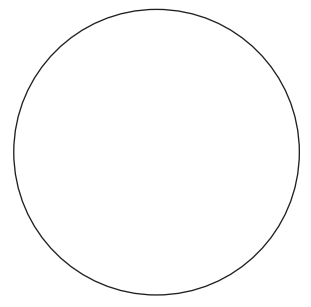

INTERIOR MATERIALS  
+ APPLICATIONS

**IDES 115**


FINISH  
SCHEDULE  
+ SPECS

DRAWN BY:  
Blankenberger | Bulmahn  
Johnson | Laird | Turner  
CHECKED BY:

SCALE: 1/4" = 1'-0"


SHEET  
**A3**

FINISH TYPE	DESCRIPTION
1	Painted with Sherwin Williams color "Ice Cube" in an eggshell finish
2	Painted with Sherwin Williams color "Ice Cube" in an eggshell finish. With accent mural painted with Sherwin Williams colors "After the Rain" and "Frolic." *See Elevation
3	
4	
5	
6	
LVT	
CPT	

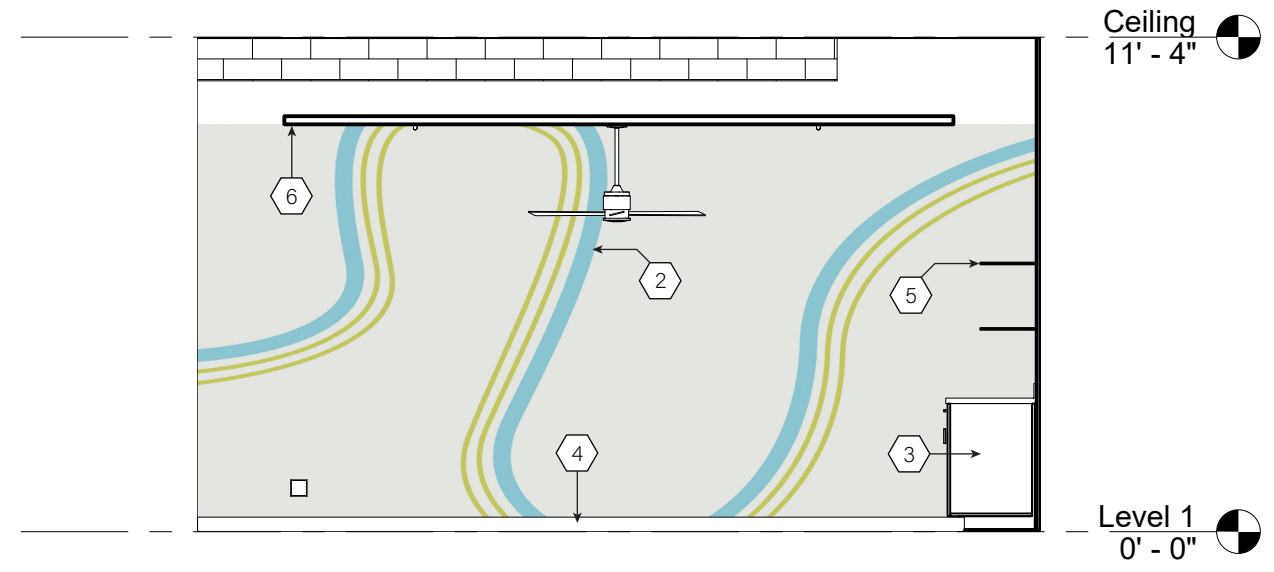


West Room - South Elevation


SYMBOL	QUANTITY	ITEM DESCRIPTION
CH-1	2	NEO Chair
CH-2	1	Biggerstaff Wide Linen Armchair
D	2	Flexispot Electric Standing
SC	1	EILIF Screen
SO	1	Dmitri Loveseat
S-1	3	Floating Shelves
S-2	12	Menards's "Dakota™ 3/4" x 15-3/4"W x 8'L Bourbon Prefinished Square Edge Shelf" Shelf board
T	2	Linon Titon End Table

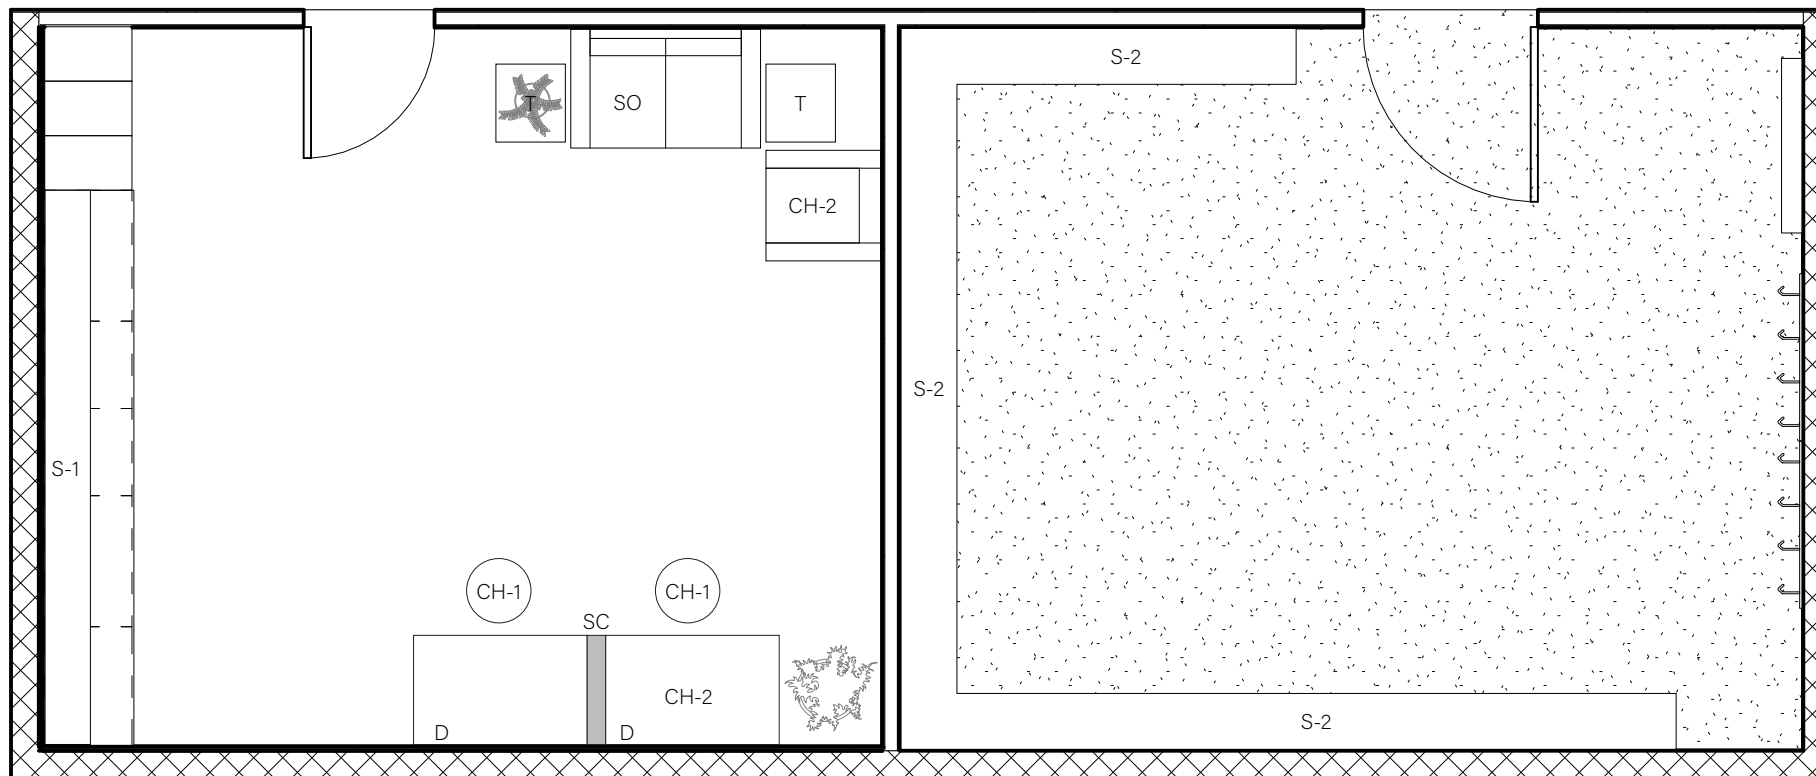

① Level 1 Furniture Plan  
1/4" = 1'-0"

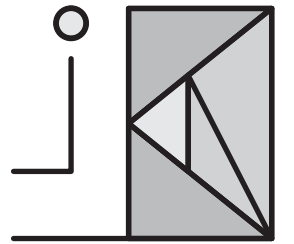

21 MARCH 2022

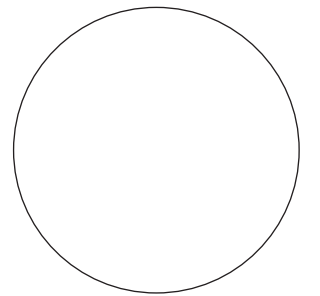

INTERIOR MATERIALS  
+ APPLICATIONS


IDES 115

KEYED  
FURNITURE  
PLAN


DRAWN BY:  
Blankenberger | Bulmahn  
Johnson | Laird | Turner  
CHECKED BY:

SCALE: 1/4" = 1'-0"

SHEET  
A4

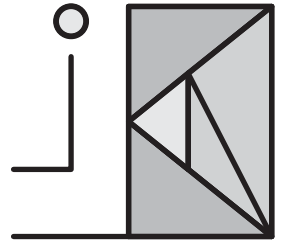

21 MARCH 2022

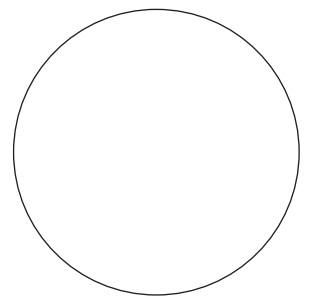

INTERIOR MATERIALS  
+ APPLICATIONS


**IDES 115**

REFLECTED  
CEILING  
PLAN


DRAWN BY:  
Blankenberger | Bulmahn  
Johnson | Laird | Turner  
CHECKED BY:

SCALE: 1/4" = 1'-0"


SHEET  
**A5**

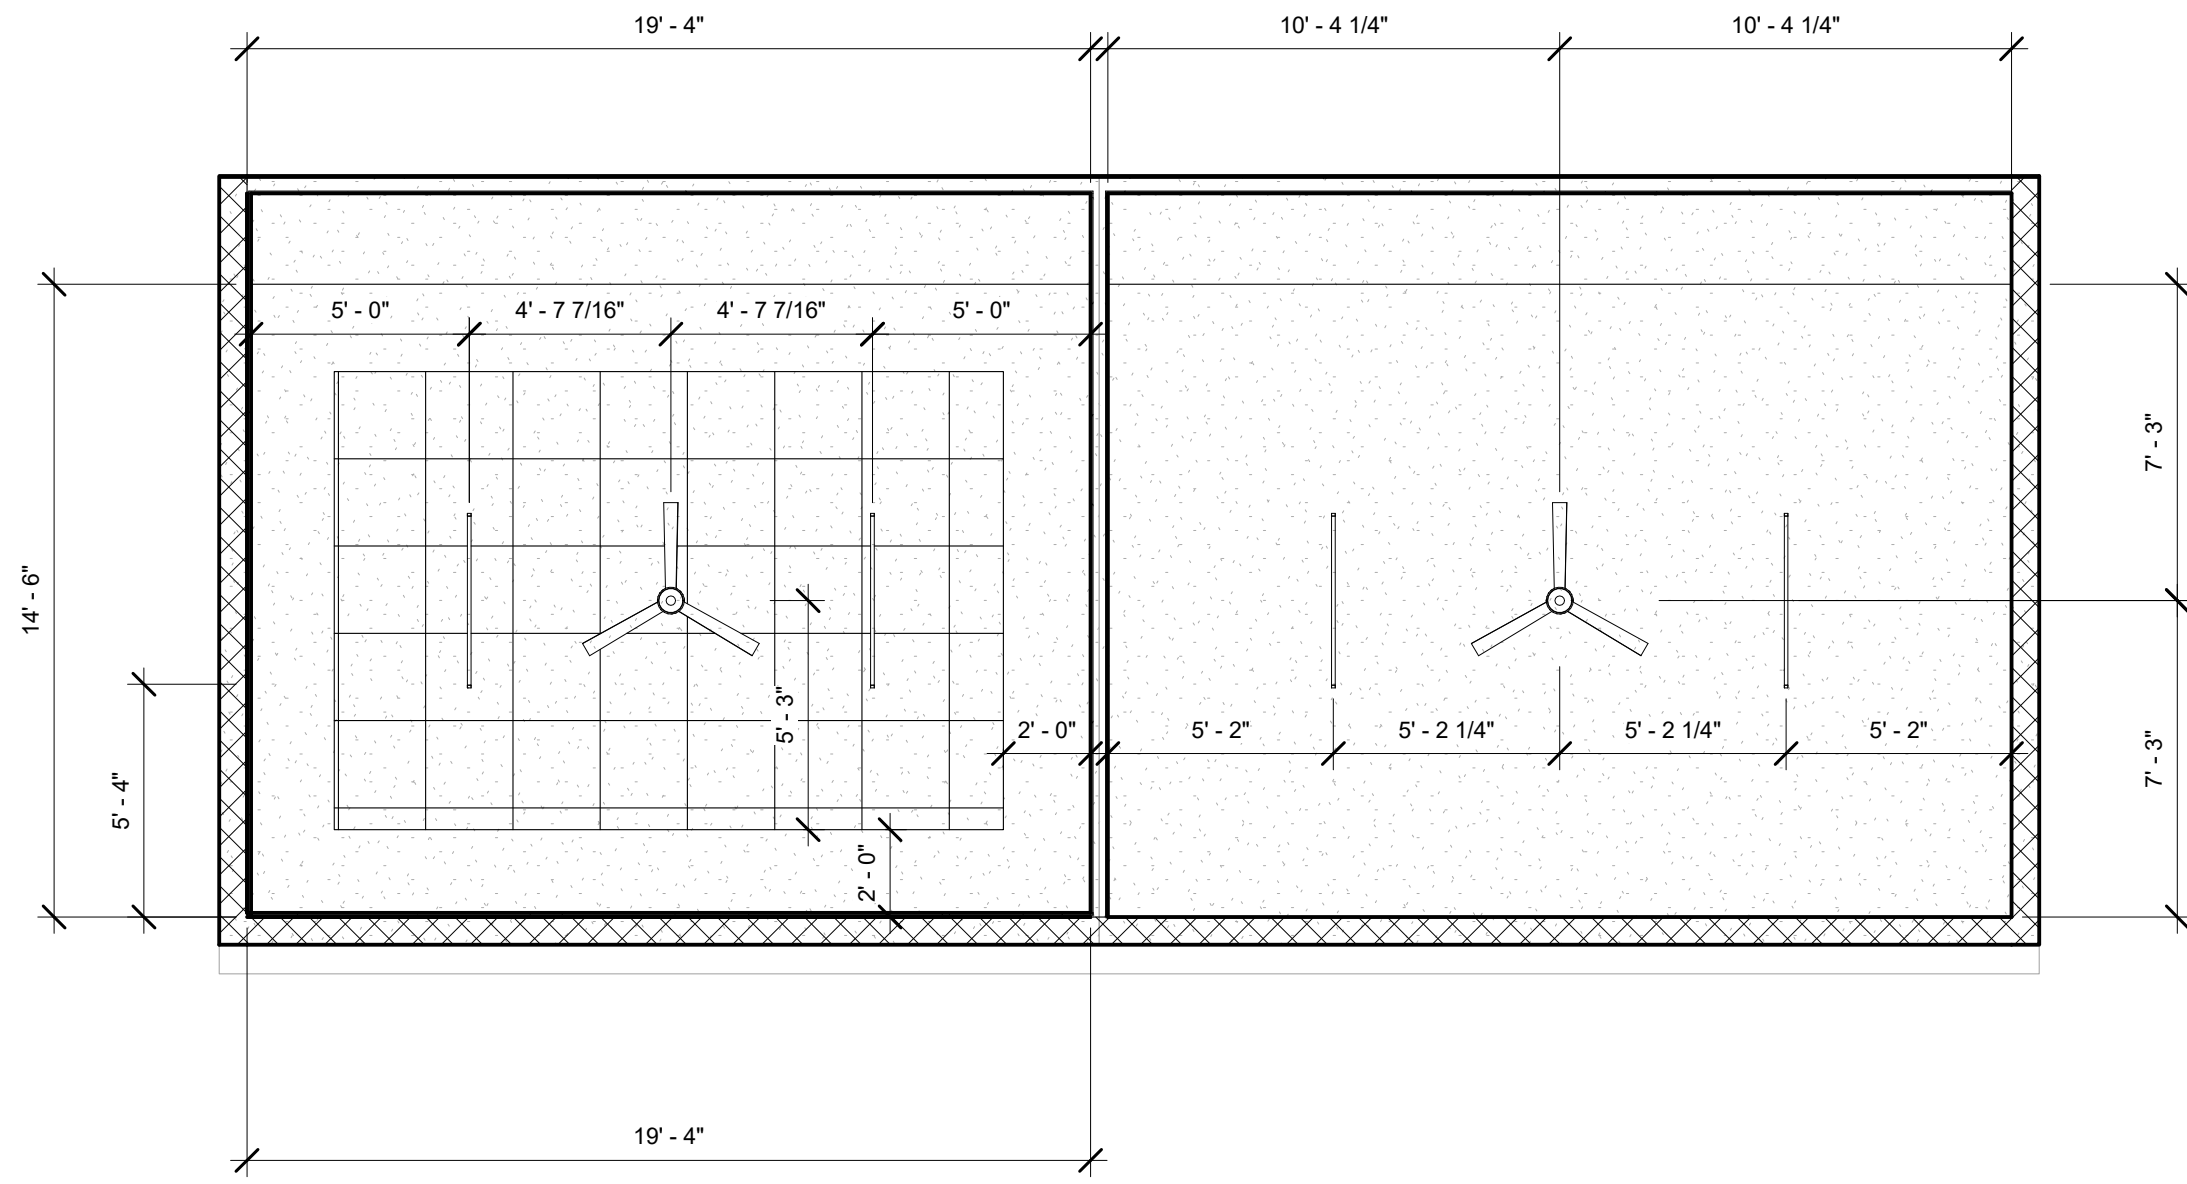


① Level 1  
1/4" = 1'-0"

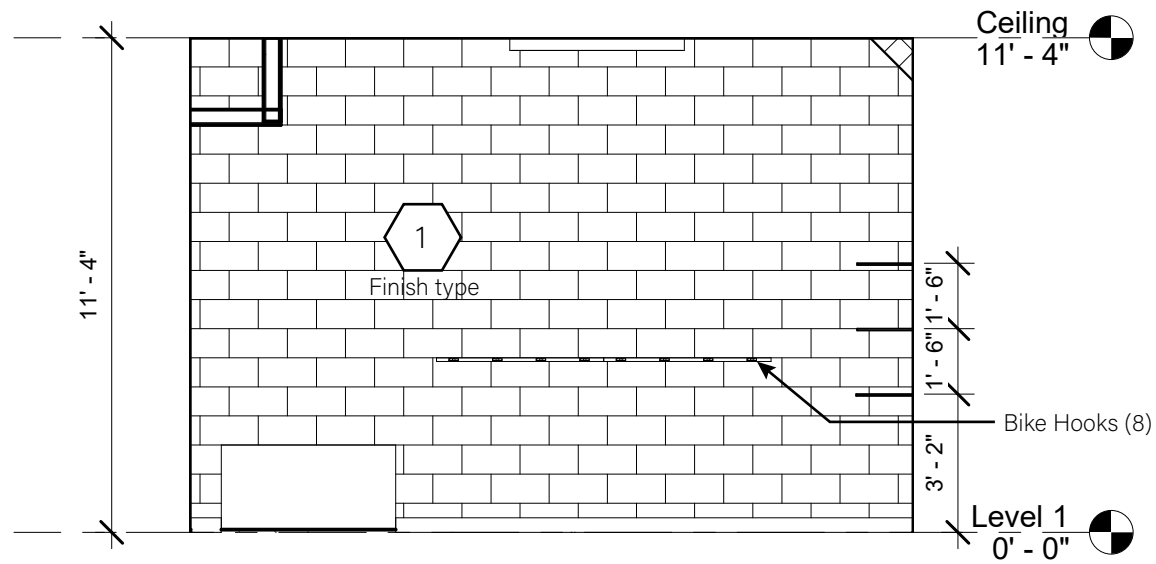


① East Room-East Elevation  
1/4" = 1'-0"

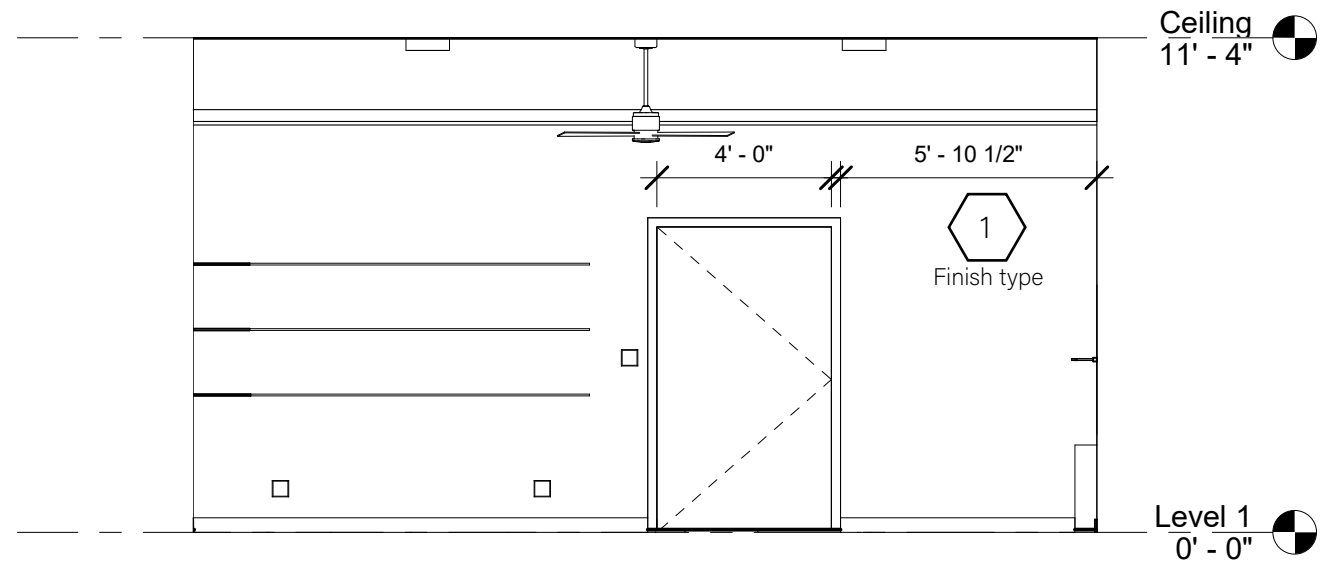


② East Room-North Elevation  
1/4" = 1'-0"

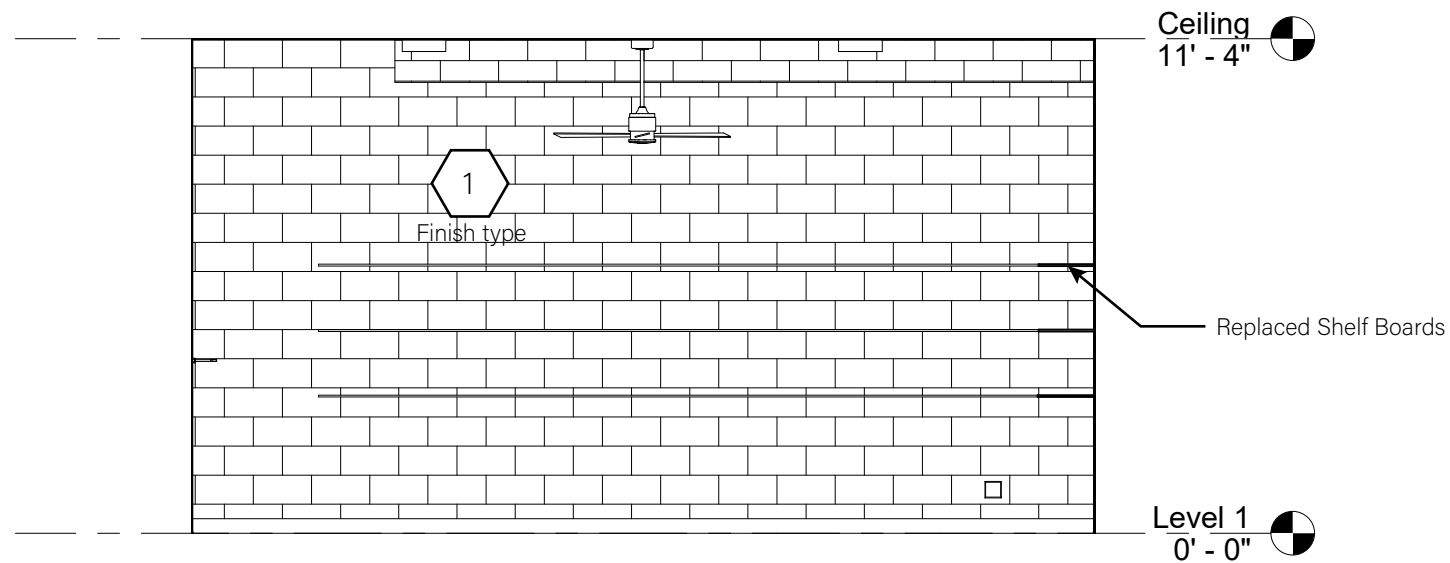


③ East Room-South Elevation  
1/4" = 1'-0"

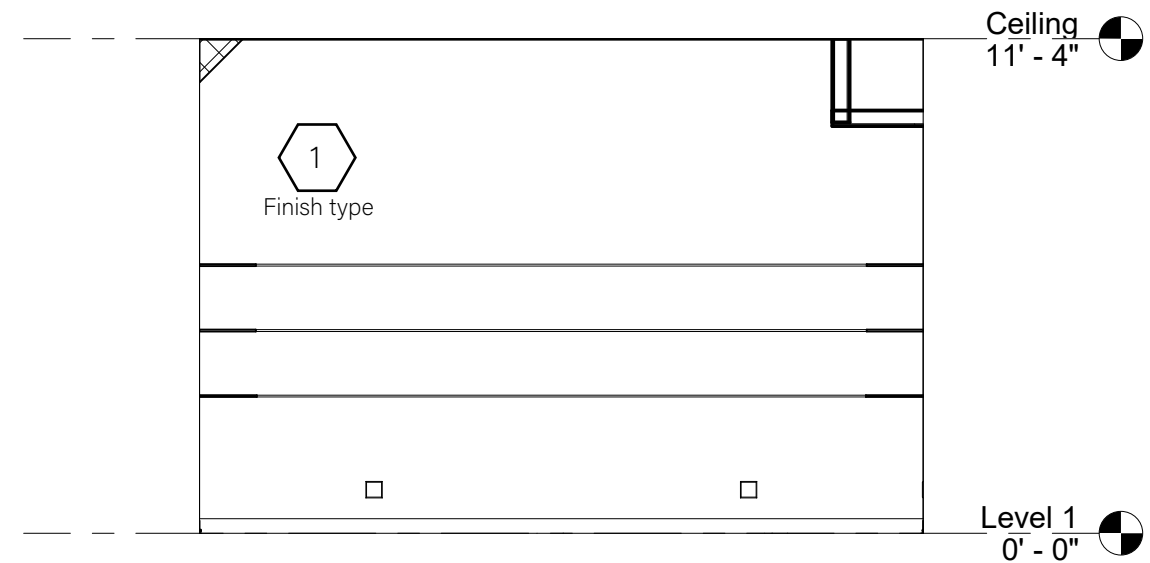

④ East Room-West Elevation  
1/4" = 1'-0"

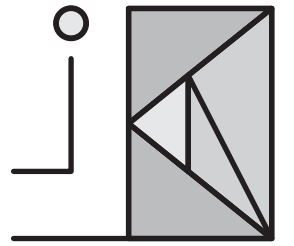

21 MARCH 2022

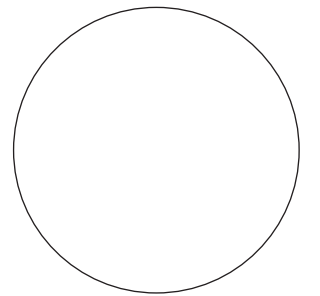

INTERIOR MATERIALS  
+ APPLICATIONS


IDES 115

INTERIOR  
ELEVATIONS  
EAST ROOM


DRAWN BY:  
Blankenberger | Bulmahn  
Johnson | Laird | Turner  
CHECKED BY:

SCALE: 1/4" = 1'-0"

SHEET  
A6.1

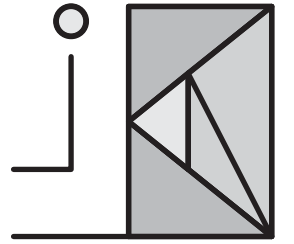

21 MARCH 2022

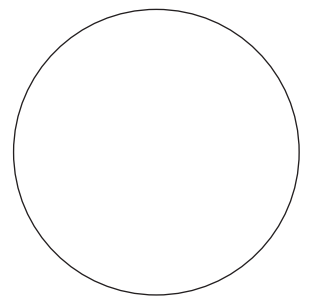

INTERIOR MATERIALS  
+ APPLICATIONS


IDES 115

INTERIOR  
ELEVATIONS  
WEST ROOM


DRAWN BY:  
Blankenberger | Bulmahn  
Johnson | Laird | Turner  
CHECKED BY:

SCALE: 1/4" = 1'-0"


SHEET  
A6.2

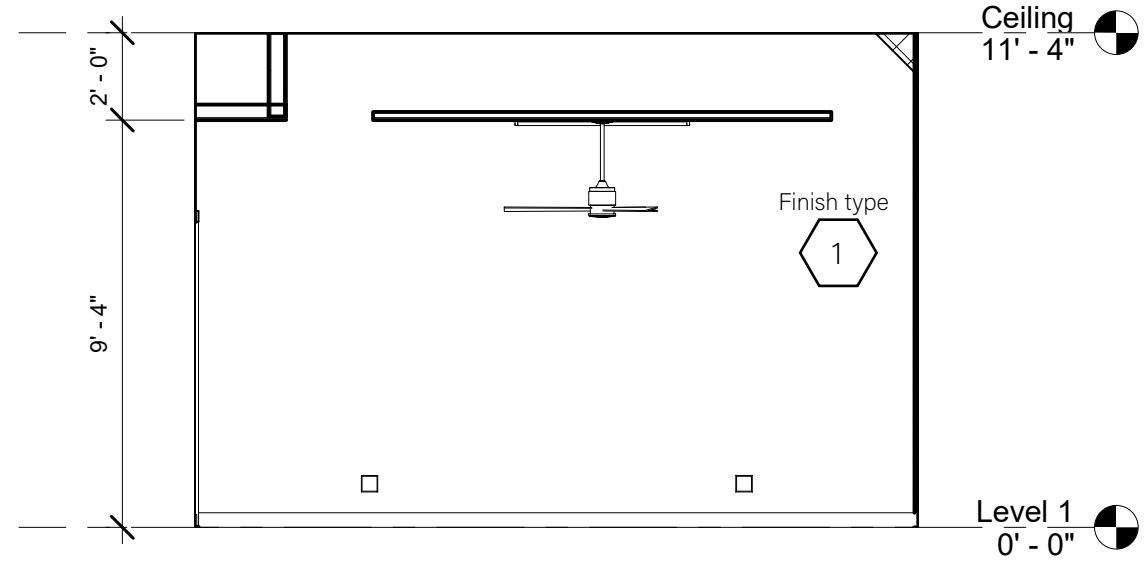


1 West Room-East Elevation  
1/4" = 1'-0"

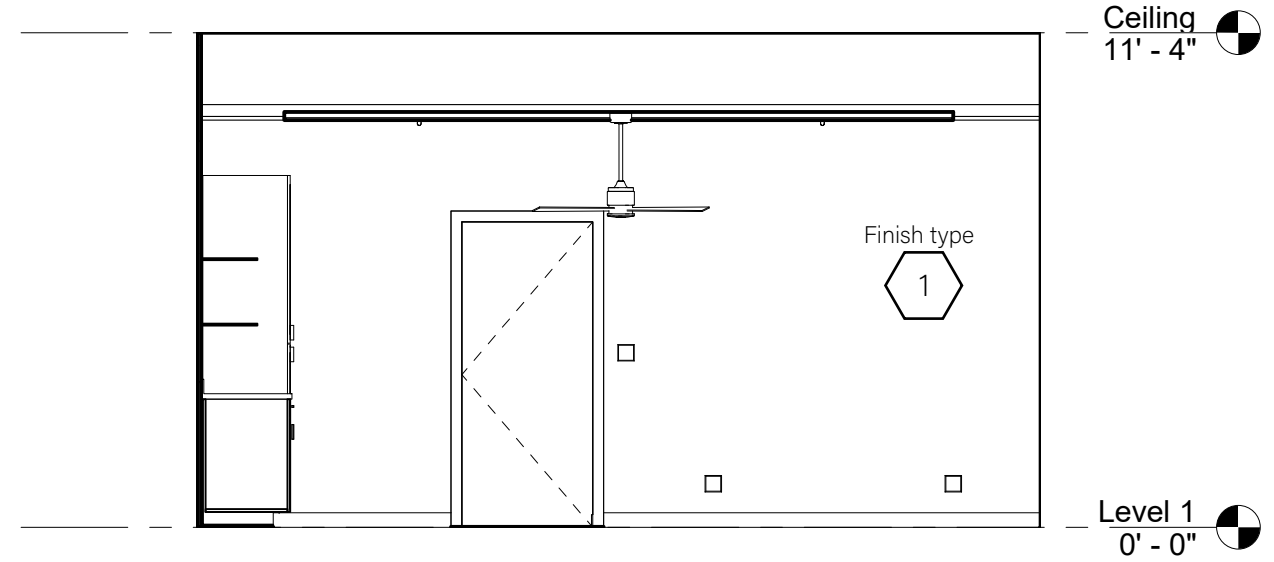

2 West Room-North Elevation  
1/4" = 1'-0"

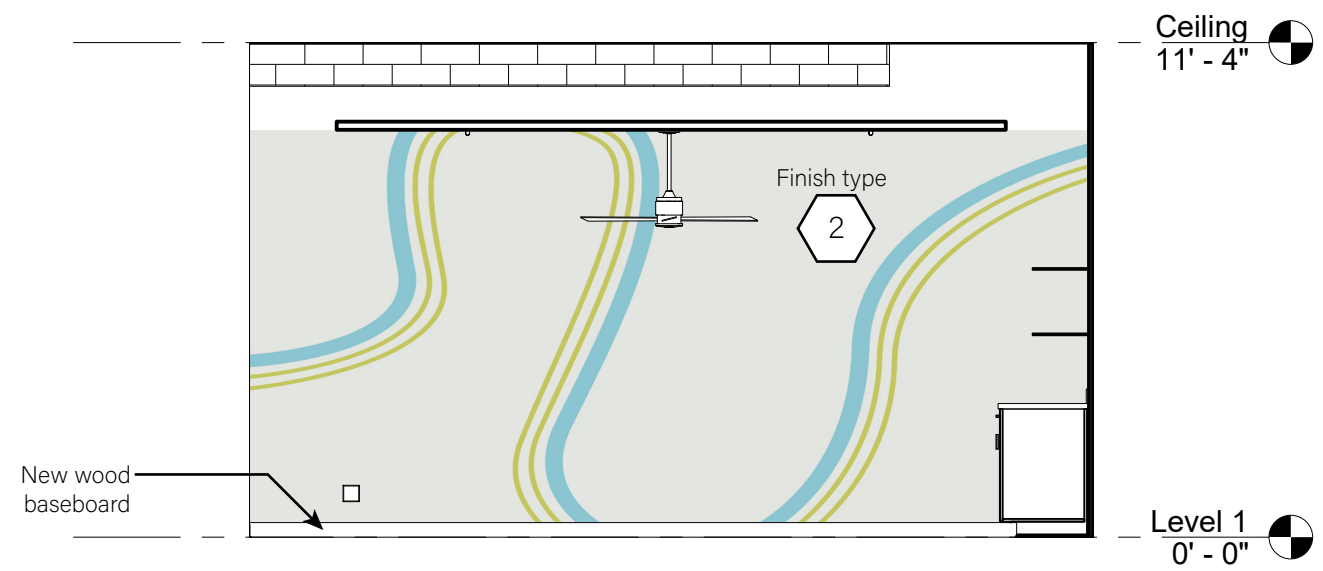


3 West Room-South Elevation  
1/4" = 1'-0"

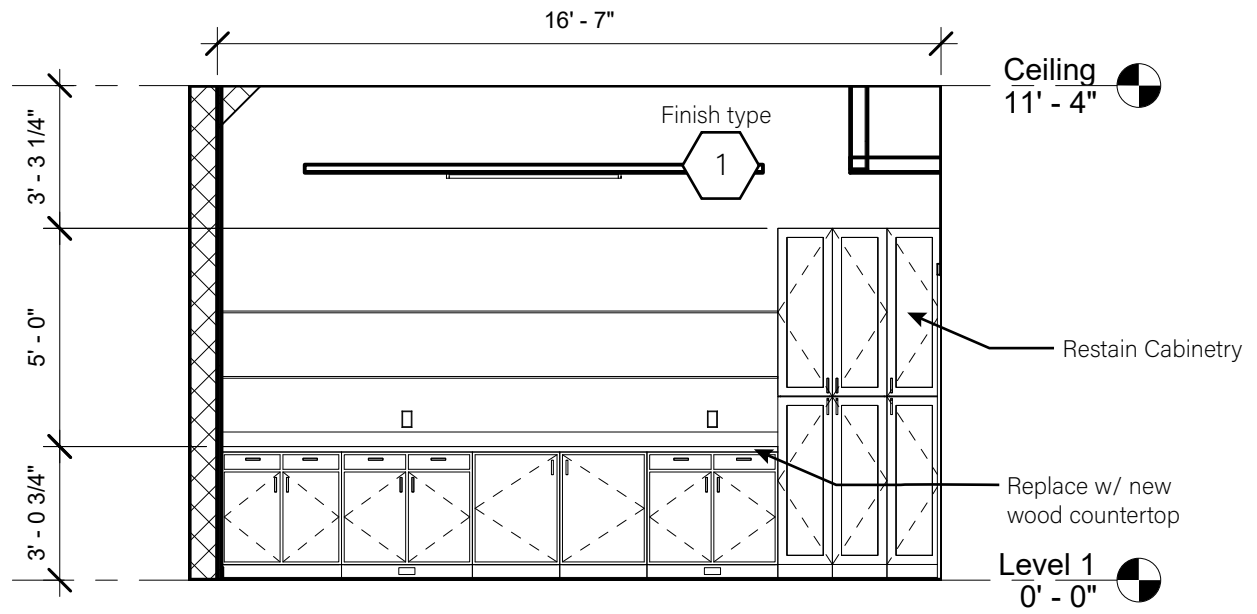


4 West Room-West View  
1/4" = 1'-0"




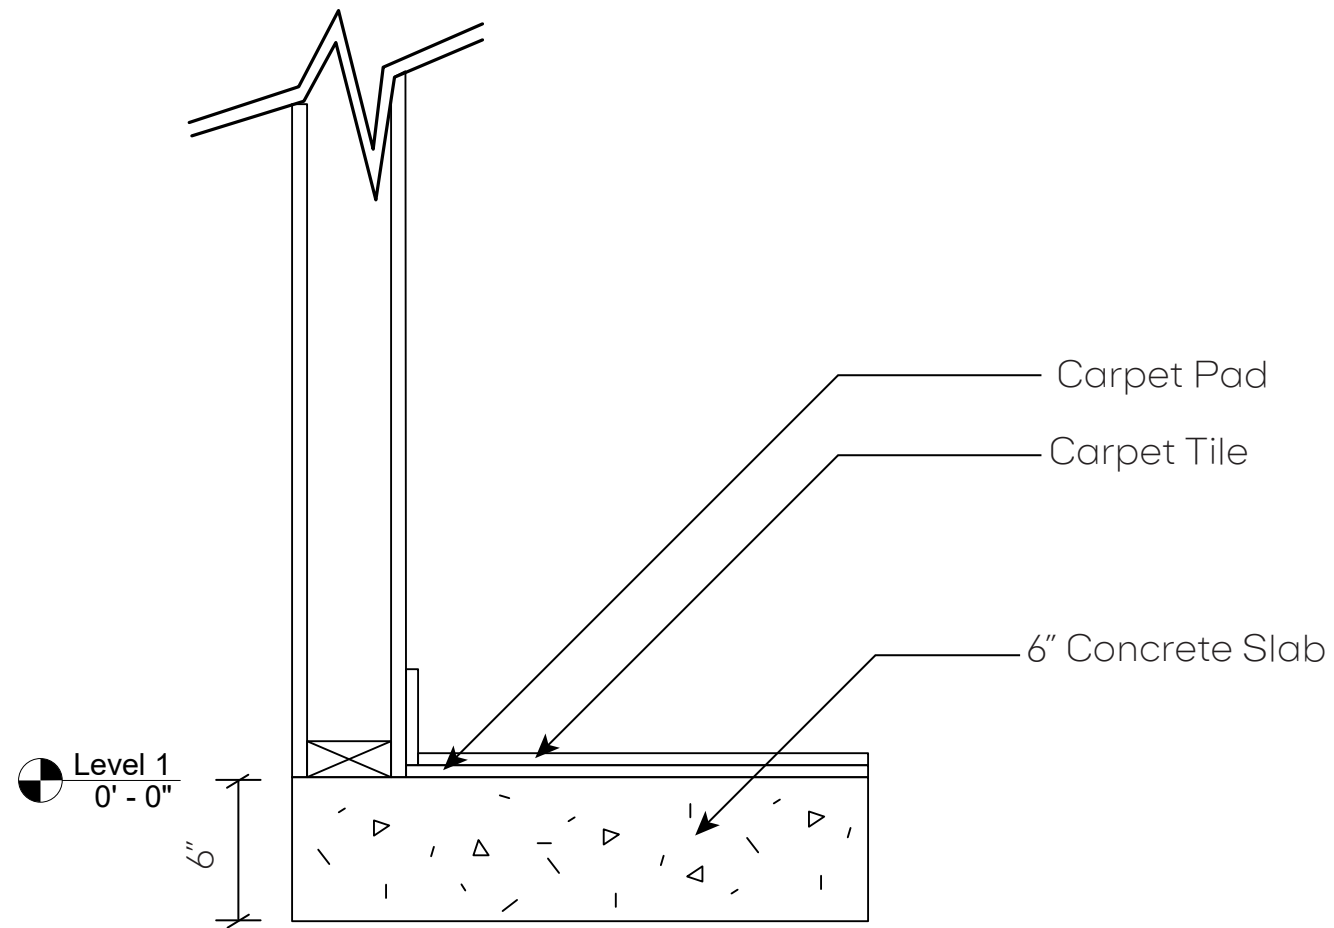


① Section 1  
1/2" = 1'-0"

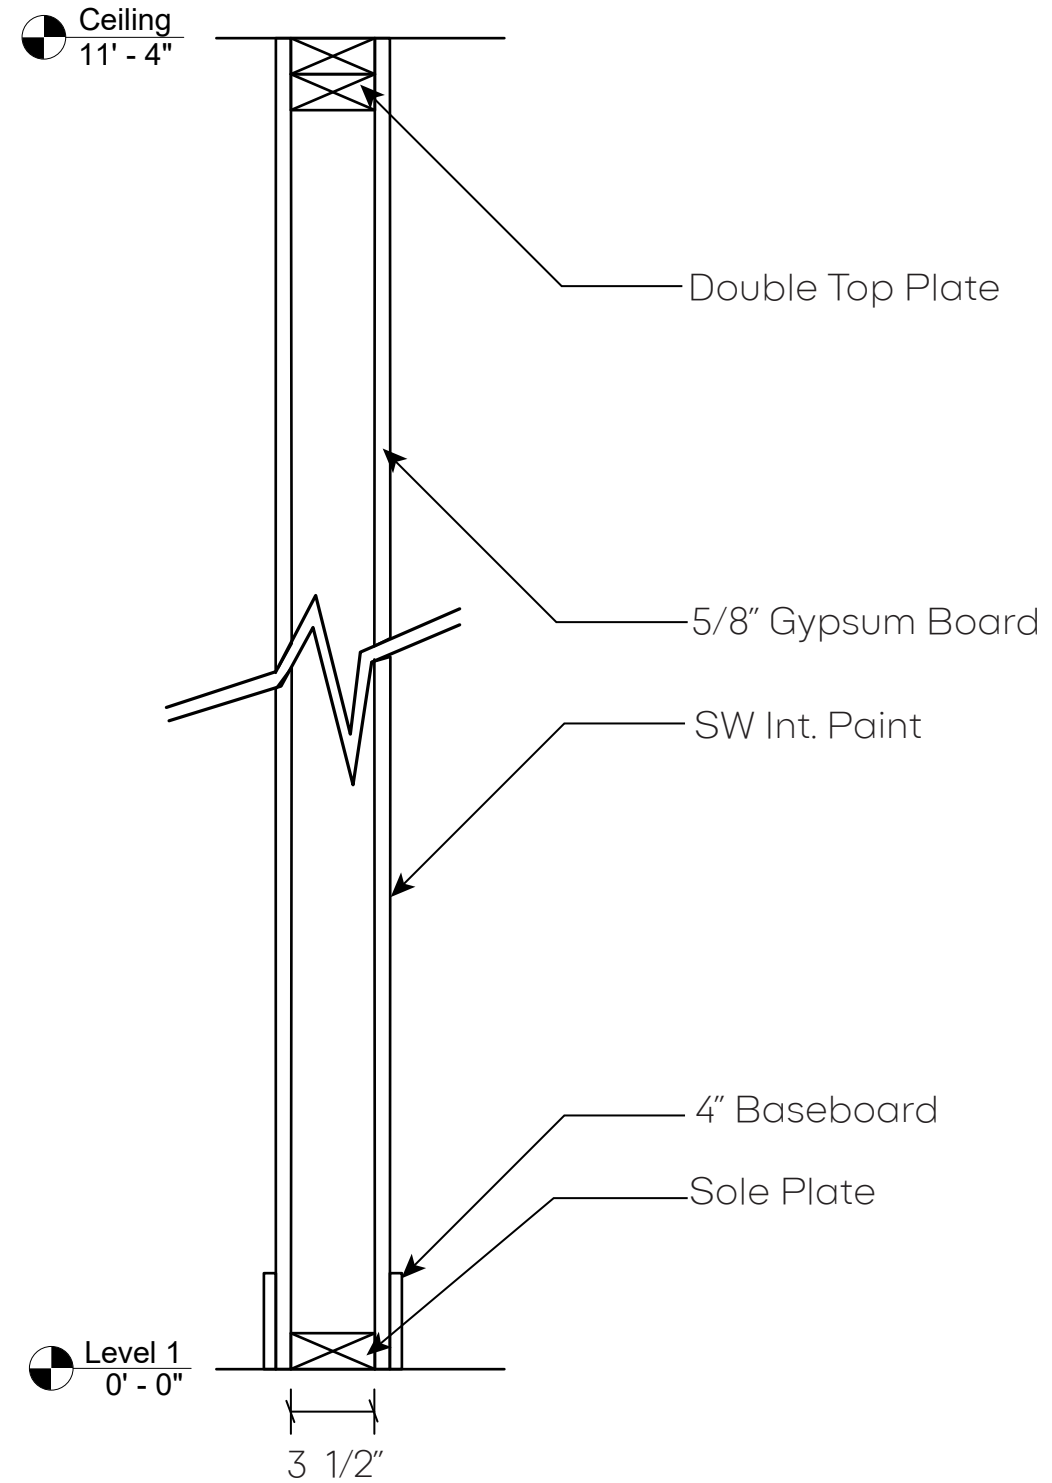

② Section 2  
1 1/2" = 1'-0"

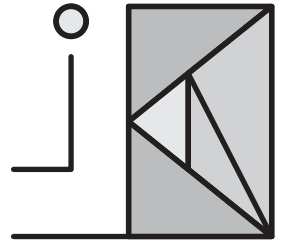

21 MARCH 2022

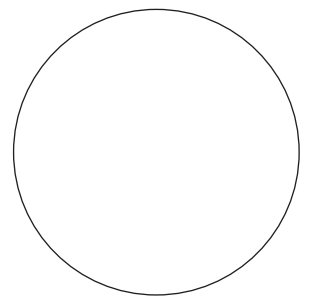

INTERIOR MATERIALS  
+ APPLICATIONS


**IDES 115**

ARCHITECTURAL  
DETAILS  
CARPET + WALL


DRAWN BY:  
Blankenberger | Bulmahn  
Johnson | Laird | Turner  
CHECKED BY:

SCALE: 1/2" = 1'-0"


SHEET  
**A7**

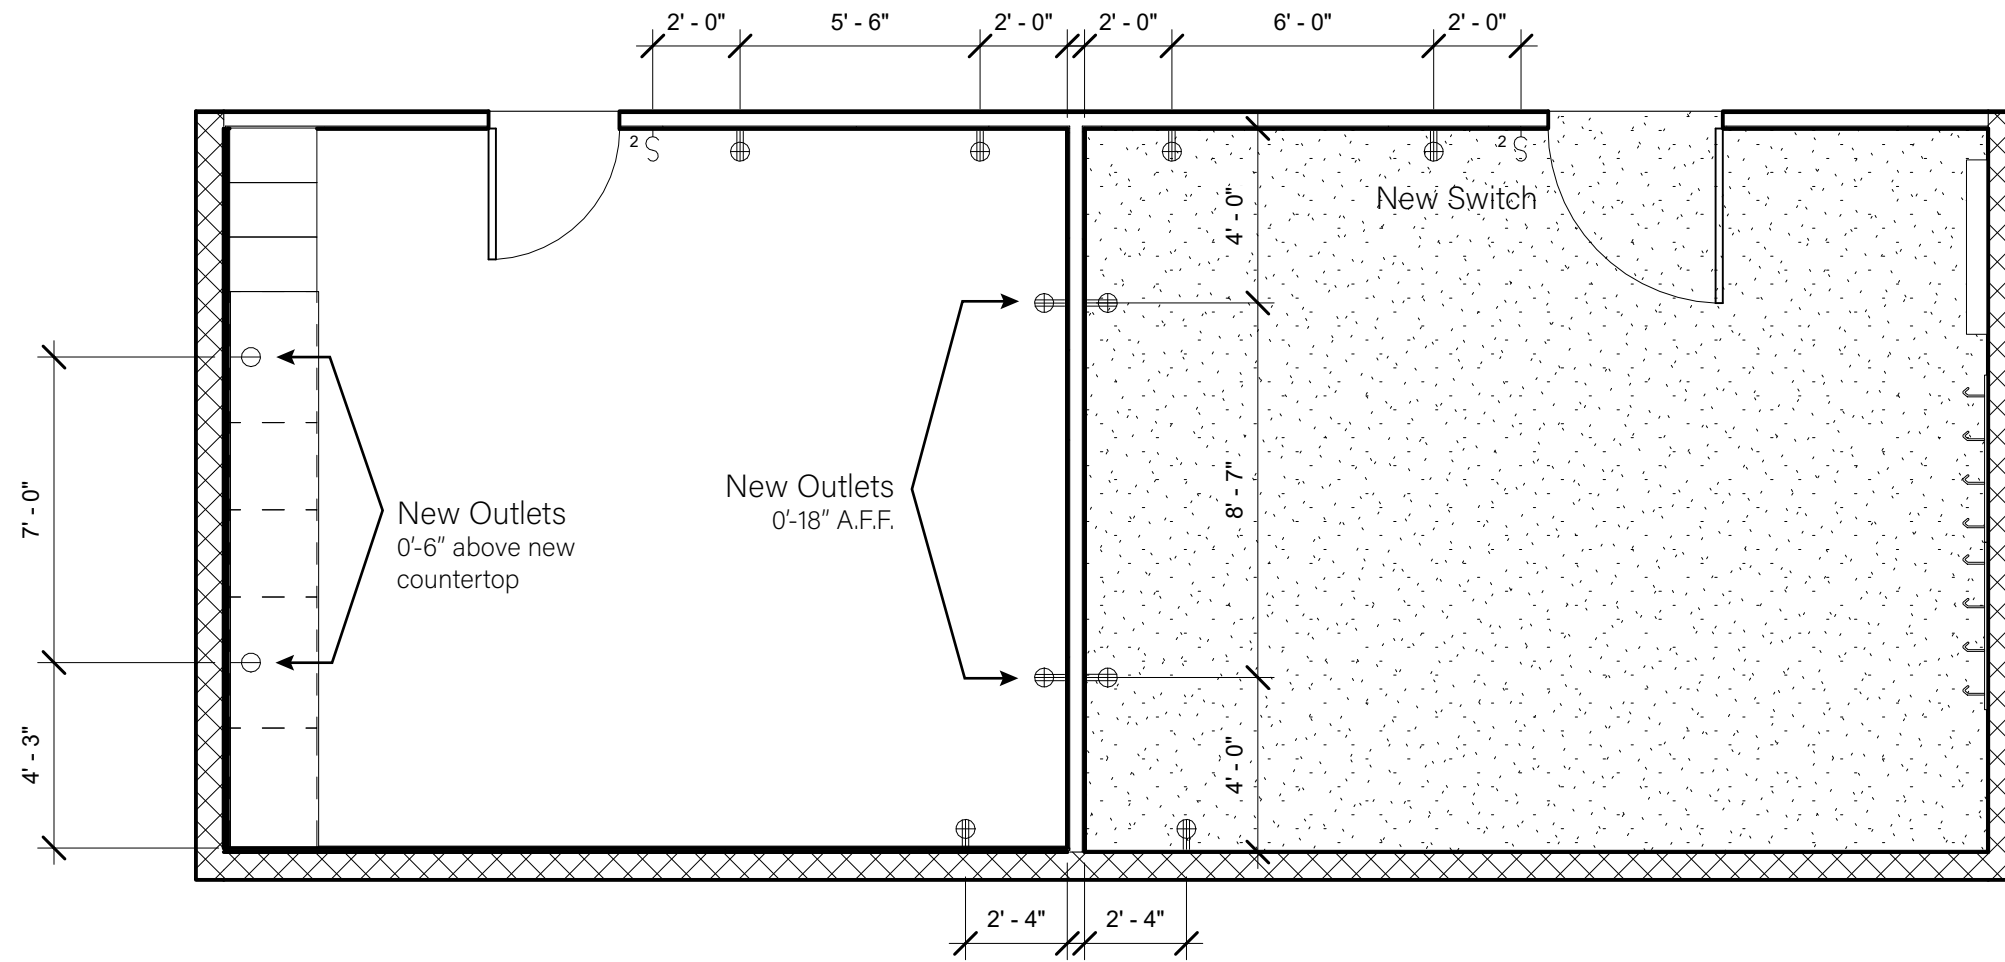

① Level 1 Electrical Plan  
1/4" = 1'-0"

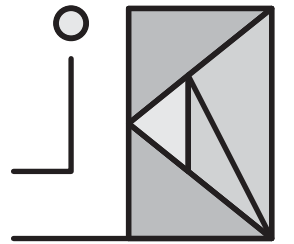

21 MARCH 2022

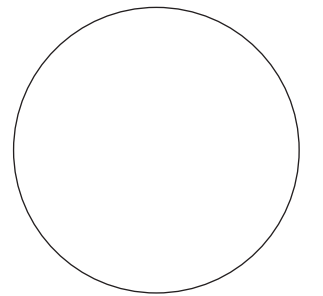

INTERIOR MATERIALS  
+ APPLICATIONS

**IDES 115**

ELECTRIC  
POWER  
+ DATA

DRAWN BY:  
Blankenberger | Bulmahn  
Johnson | Laird | Turner  
CHECKED BY:

SCALE: 1/4" = 1'-0"

SHEET  
**A8**

# First Presbyterian Church Proposal

*'natura practicus'*

